


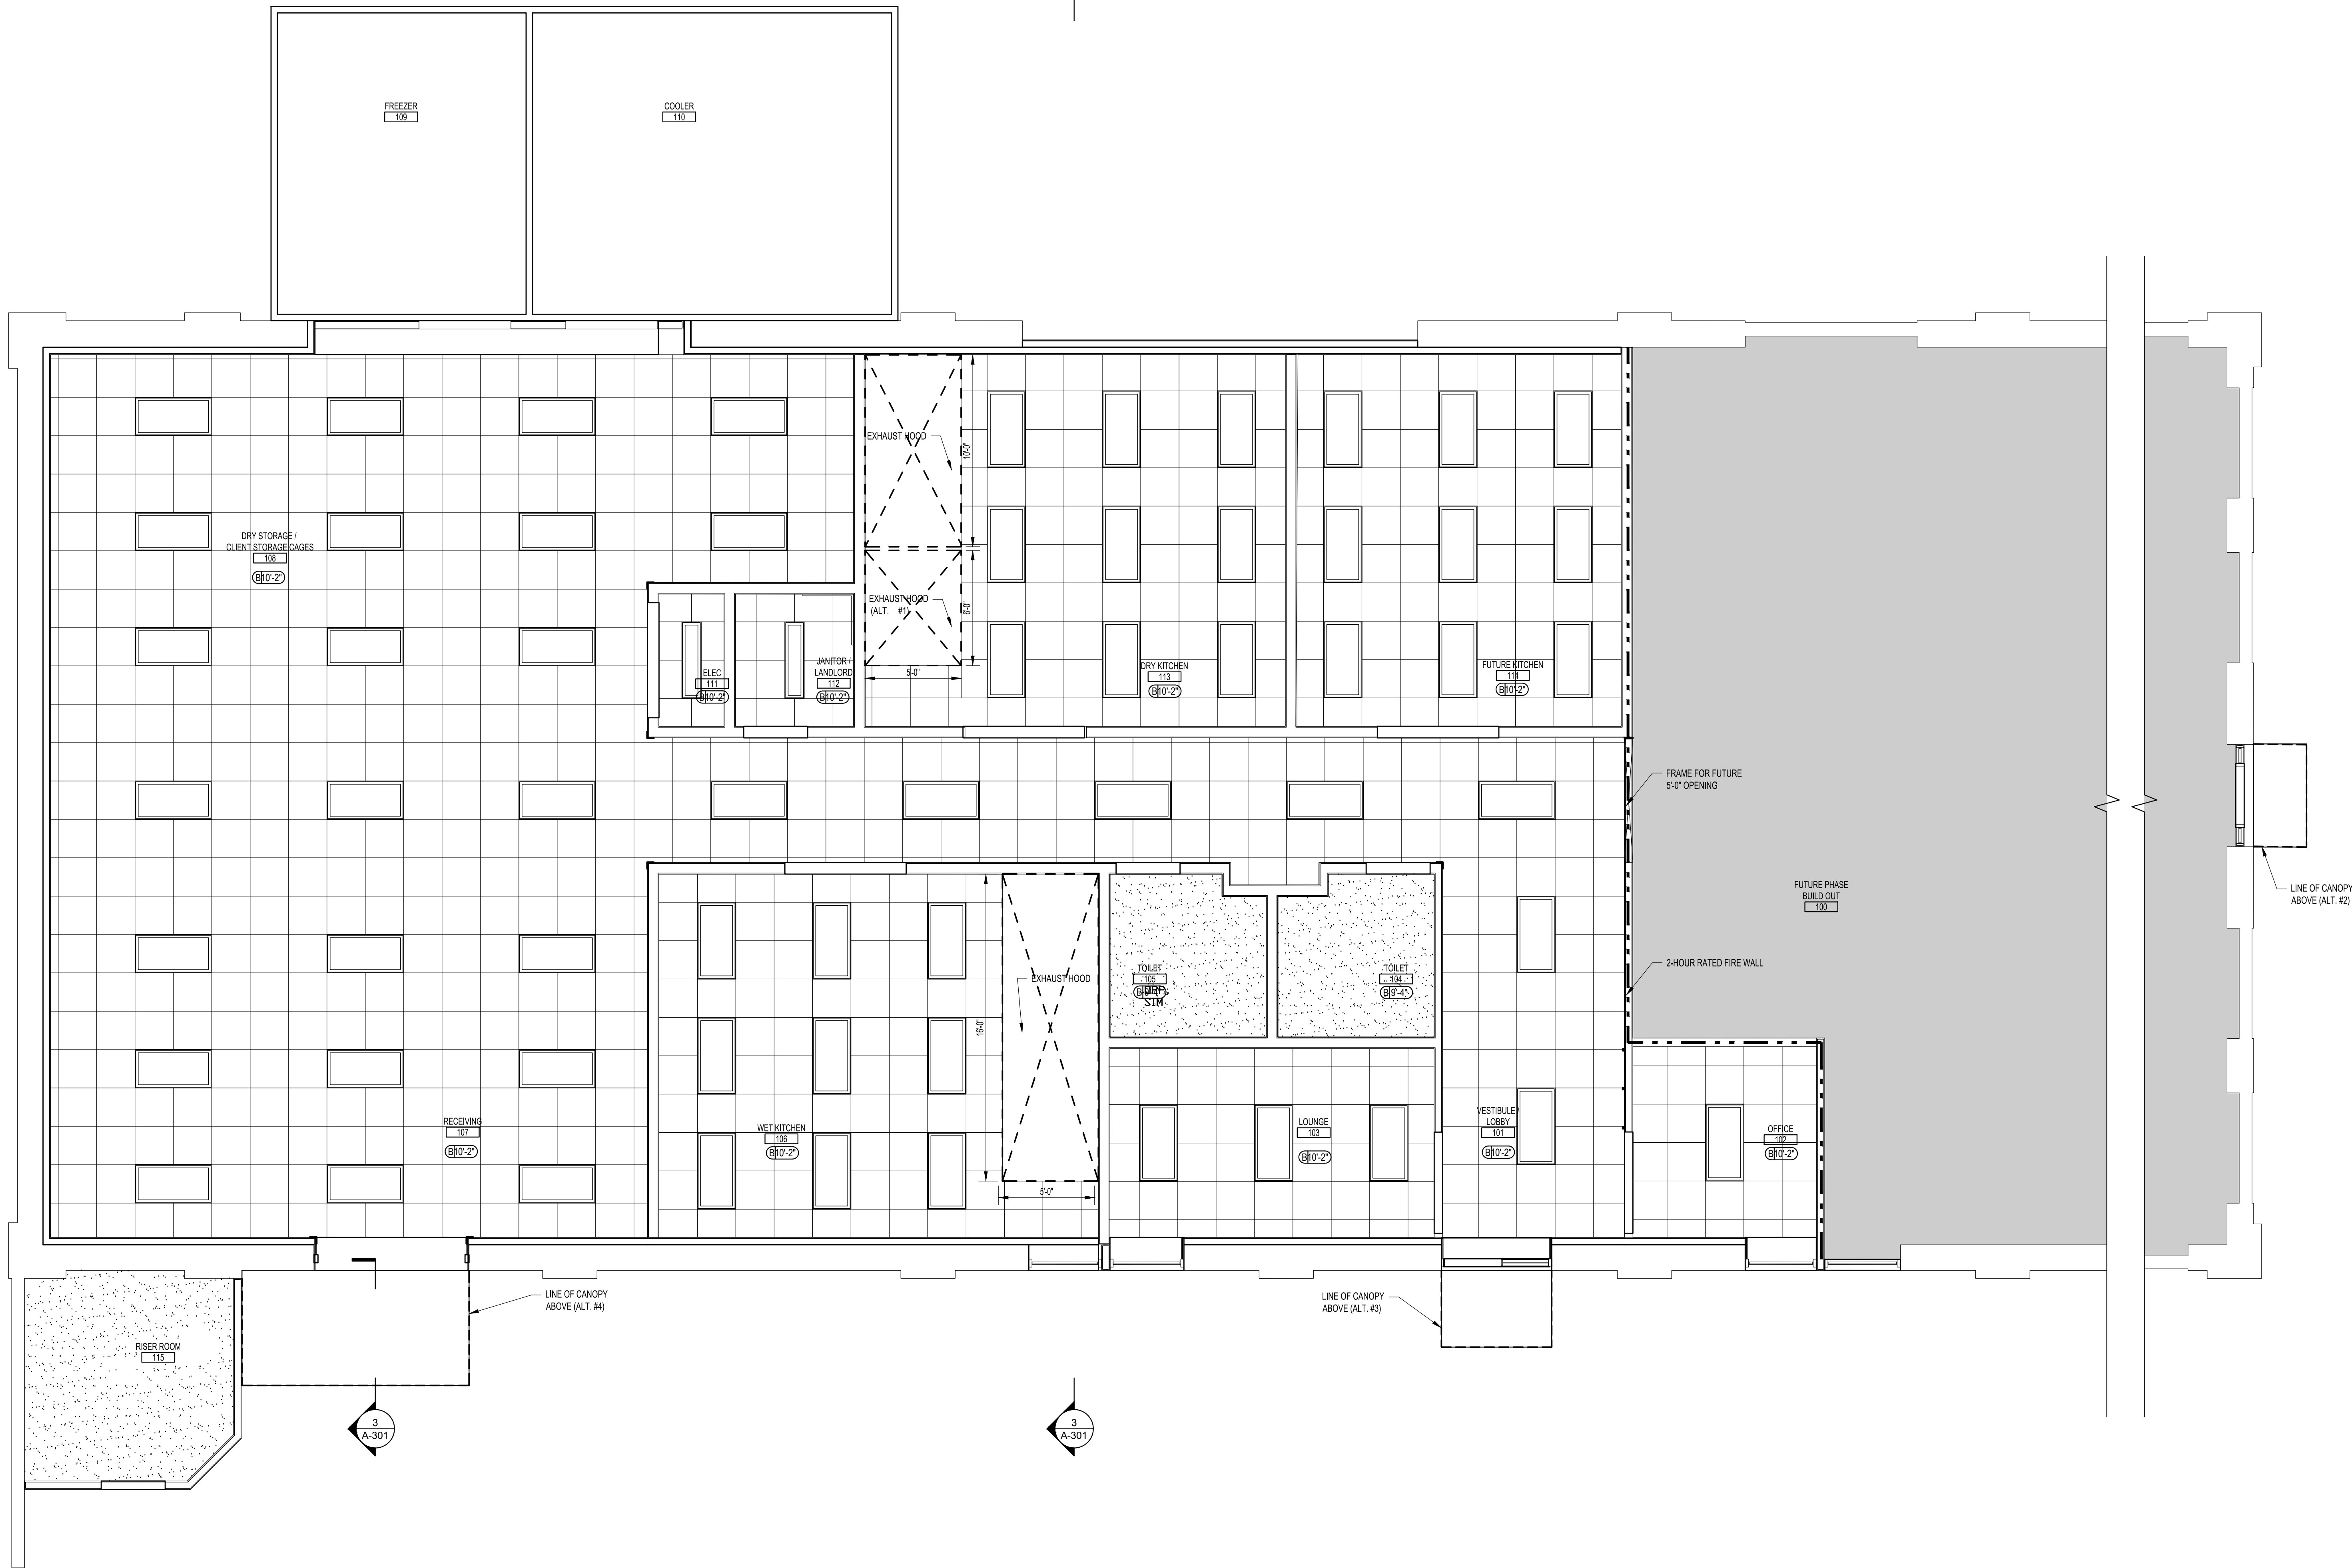

1 REFLECTED CEILING PLAN
Scale: 1/4" = 1'-0"

CEED
THE TRAINING STATION
CULINARY INCUBATOR
415 WEST RUSSELL STREET, FAYETTEVILLE, NC 28301

REVISION DATE:		
ID	DATE	DESCRIPTION
ISSUE DATE: 01/23/2018		
PROJECT #: 01606.000		
DRAWN BY: CMF, LKM		
CHECKED BY: CMF		
© 2016 Sfl+a Architects, PA All Rights Reserved		

REFLECTED CEILING
PLAN