


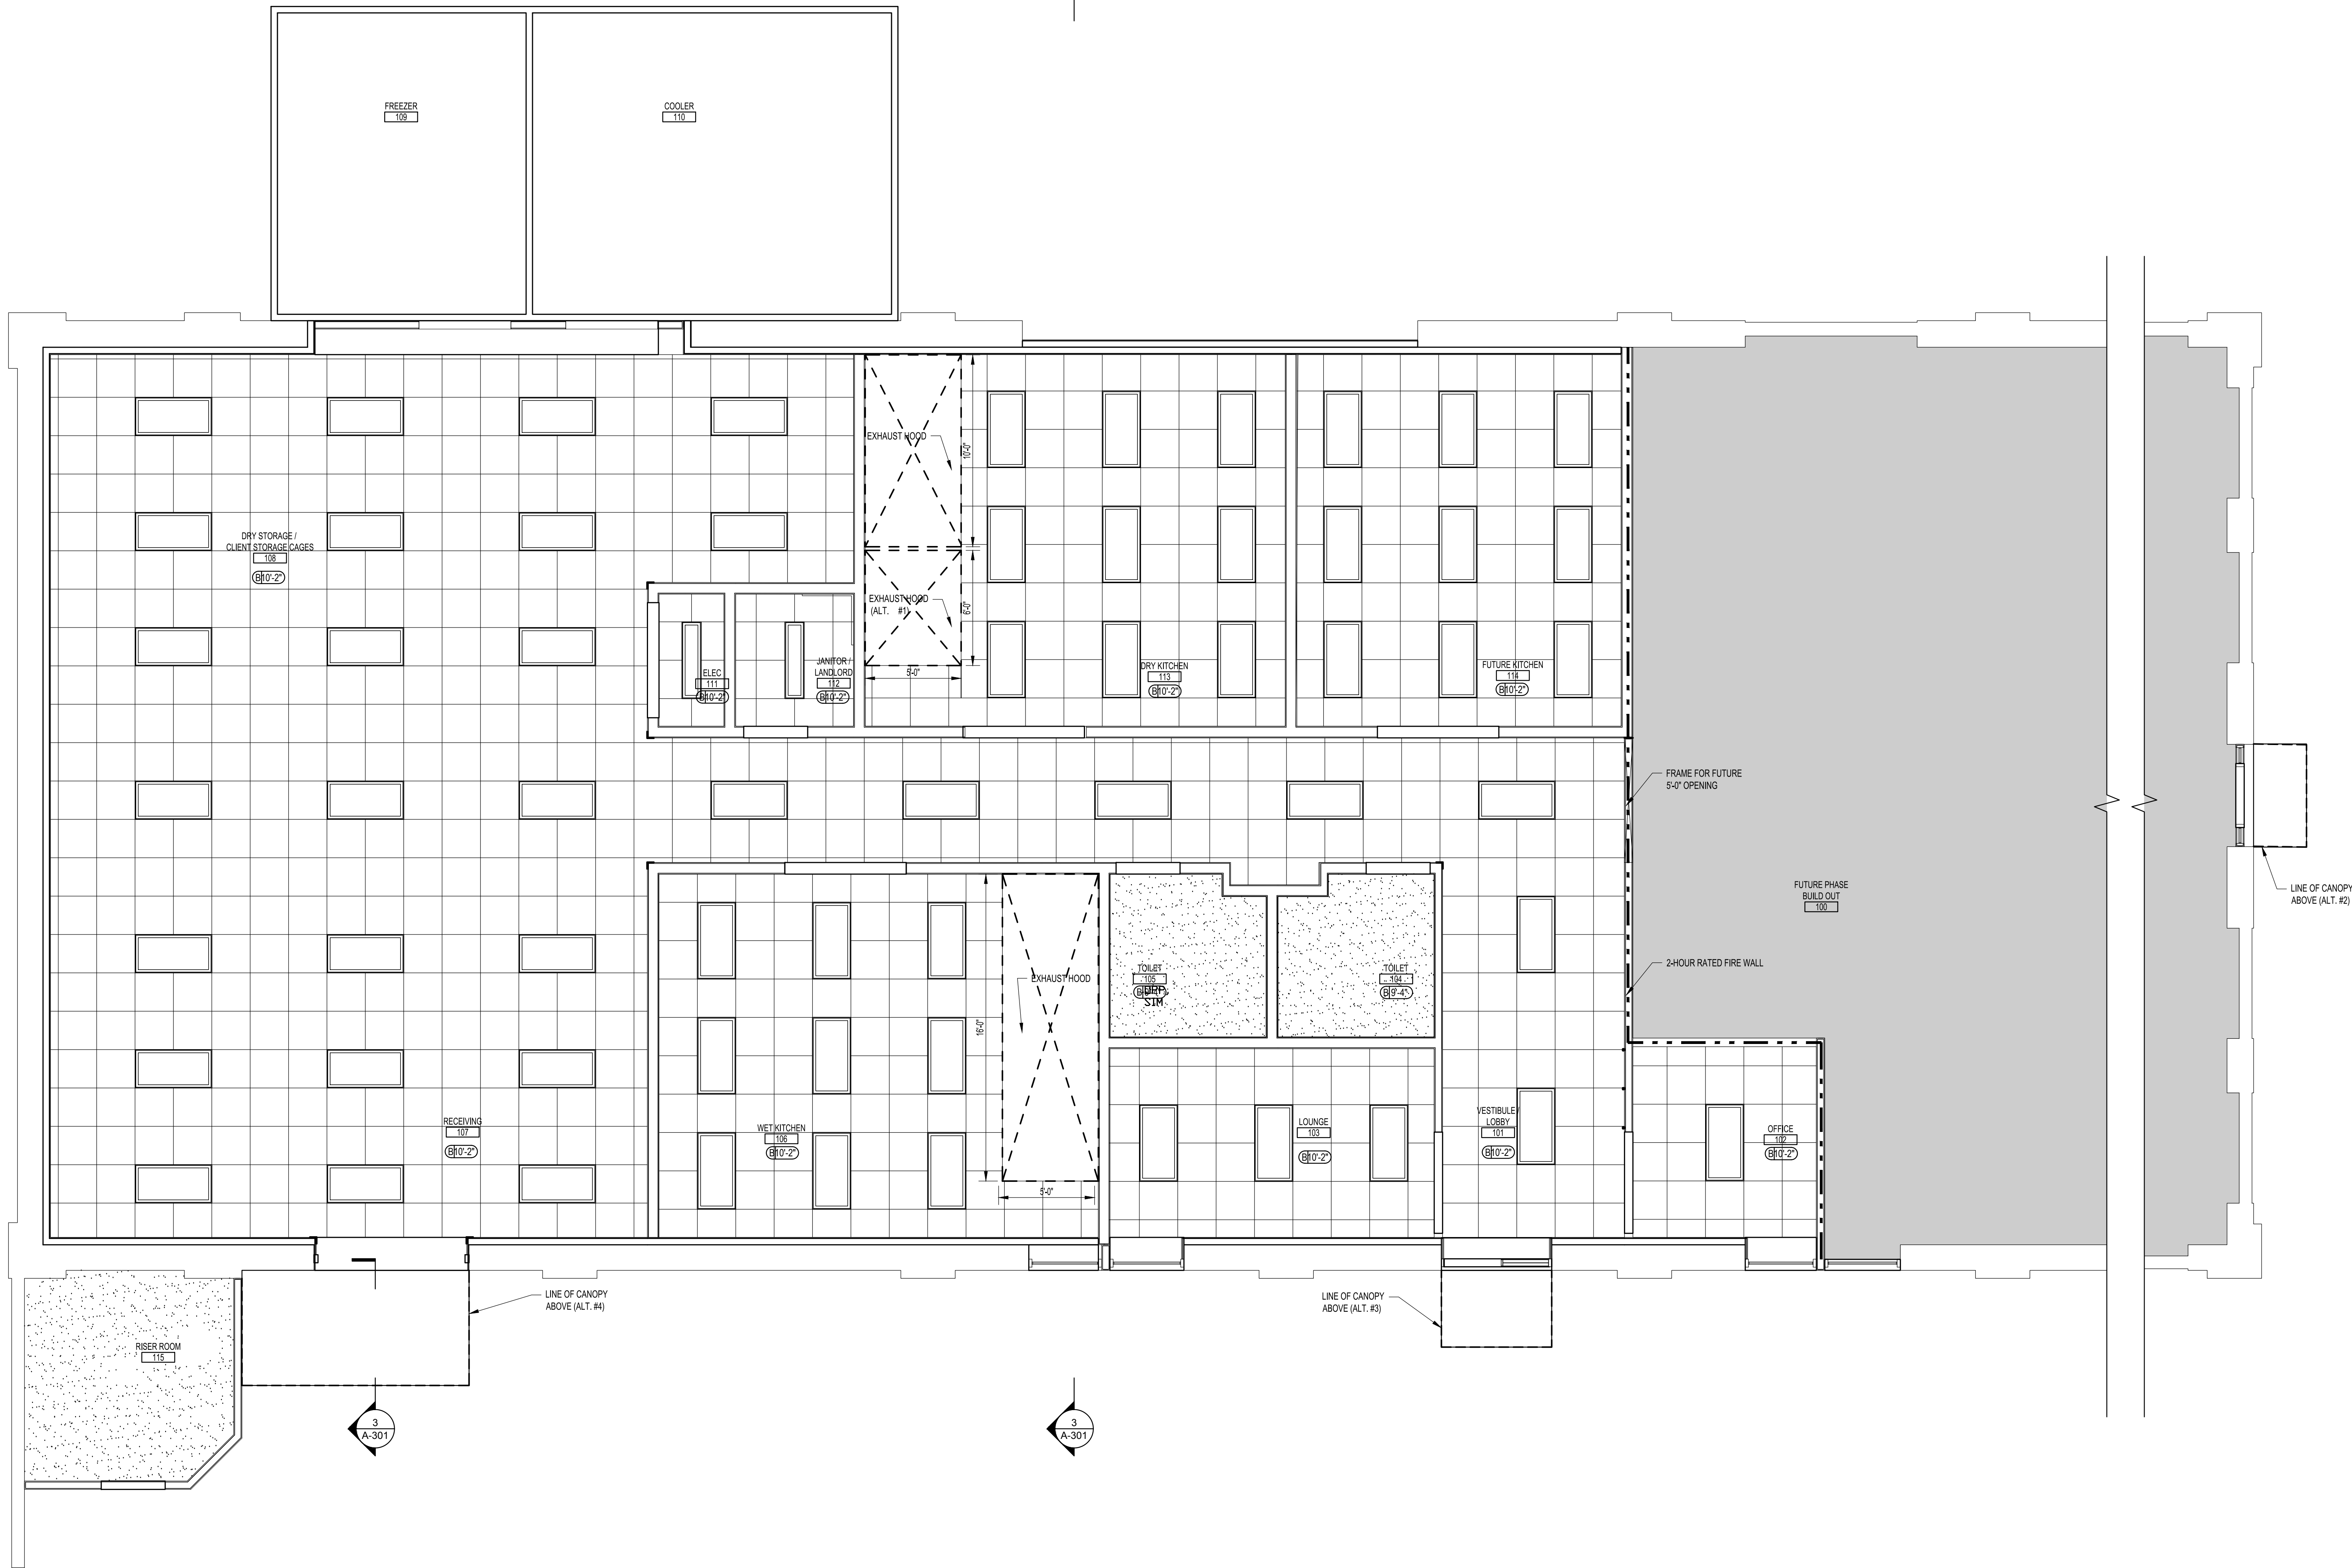


1 REFLECTED CEILING PLAN
Scale: 1/4" = 1'-0"

Becoming the
Leading Designer of
High Performance Facilities
in the Nation with a
Specialty in Alternative
Delivery Methods

110 Anderson Street
Fayetteville, NC 28301
Phone: 910.484.4989
Fax: 919.573.6355
www.sfl+a.biz

sfl+a
ARCHITECTS

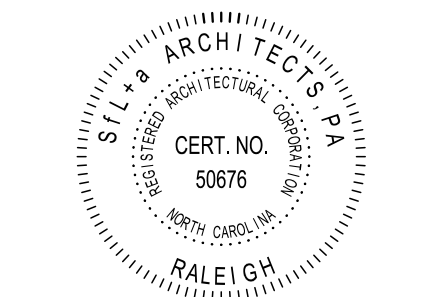

NOT FOR CONSTRUCTION
FOR REVIEW

CEED
THE TRAINING STATION
CULINARY INCUBATOR
415 WEST RUSSELL STREET, FAYETTEVILLE, NC 28301

REVISION DATE:		
ID	DATE	DESCRIPTION

ISSUE DATE: 01/23/2018

PROJECT #: 01606.000
DRAWN BY: CMF, LKM
CHECKED BY: CMF

© 2016 Sfl+a Architects, PA
All Rights Reserved

REFLECTED CEILING
PLAN